


- Legend**
- Planning Application Site Boundary (5.85H)
 - - - Existing Surface Water Drain
 - Flow Direction
 - Proposed 300mmØ HDPE Slotted Drainage
 - Proposed Manhole
 - └┘ Proposed Headwall
 - ▶ Direction of Drainage
 - Existing Ground Contour


1m Contours/NDVI/Aspect/Slope -
© Bluesky International Ltd.

Proposed Drainage Layout
Subject to Detail Design

Note:
See Drawing P21-287-0300-0002 for
Drainage Sections A-A & B-B

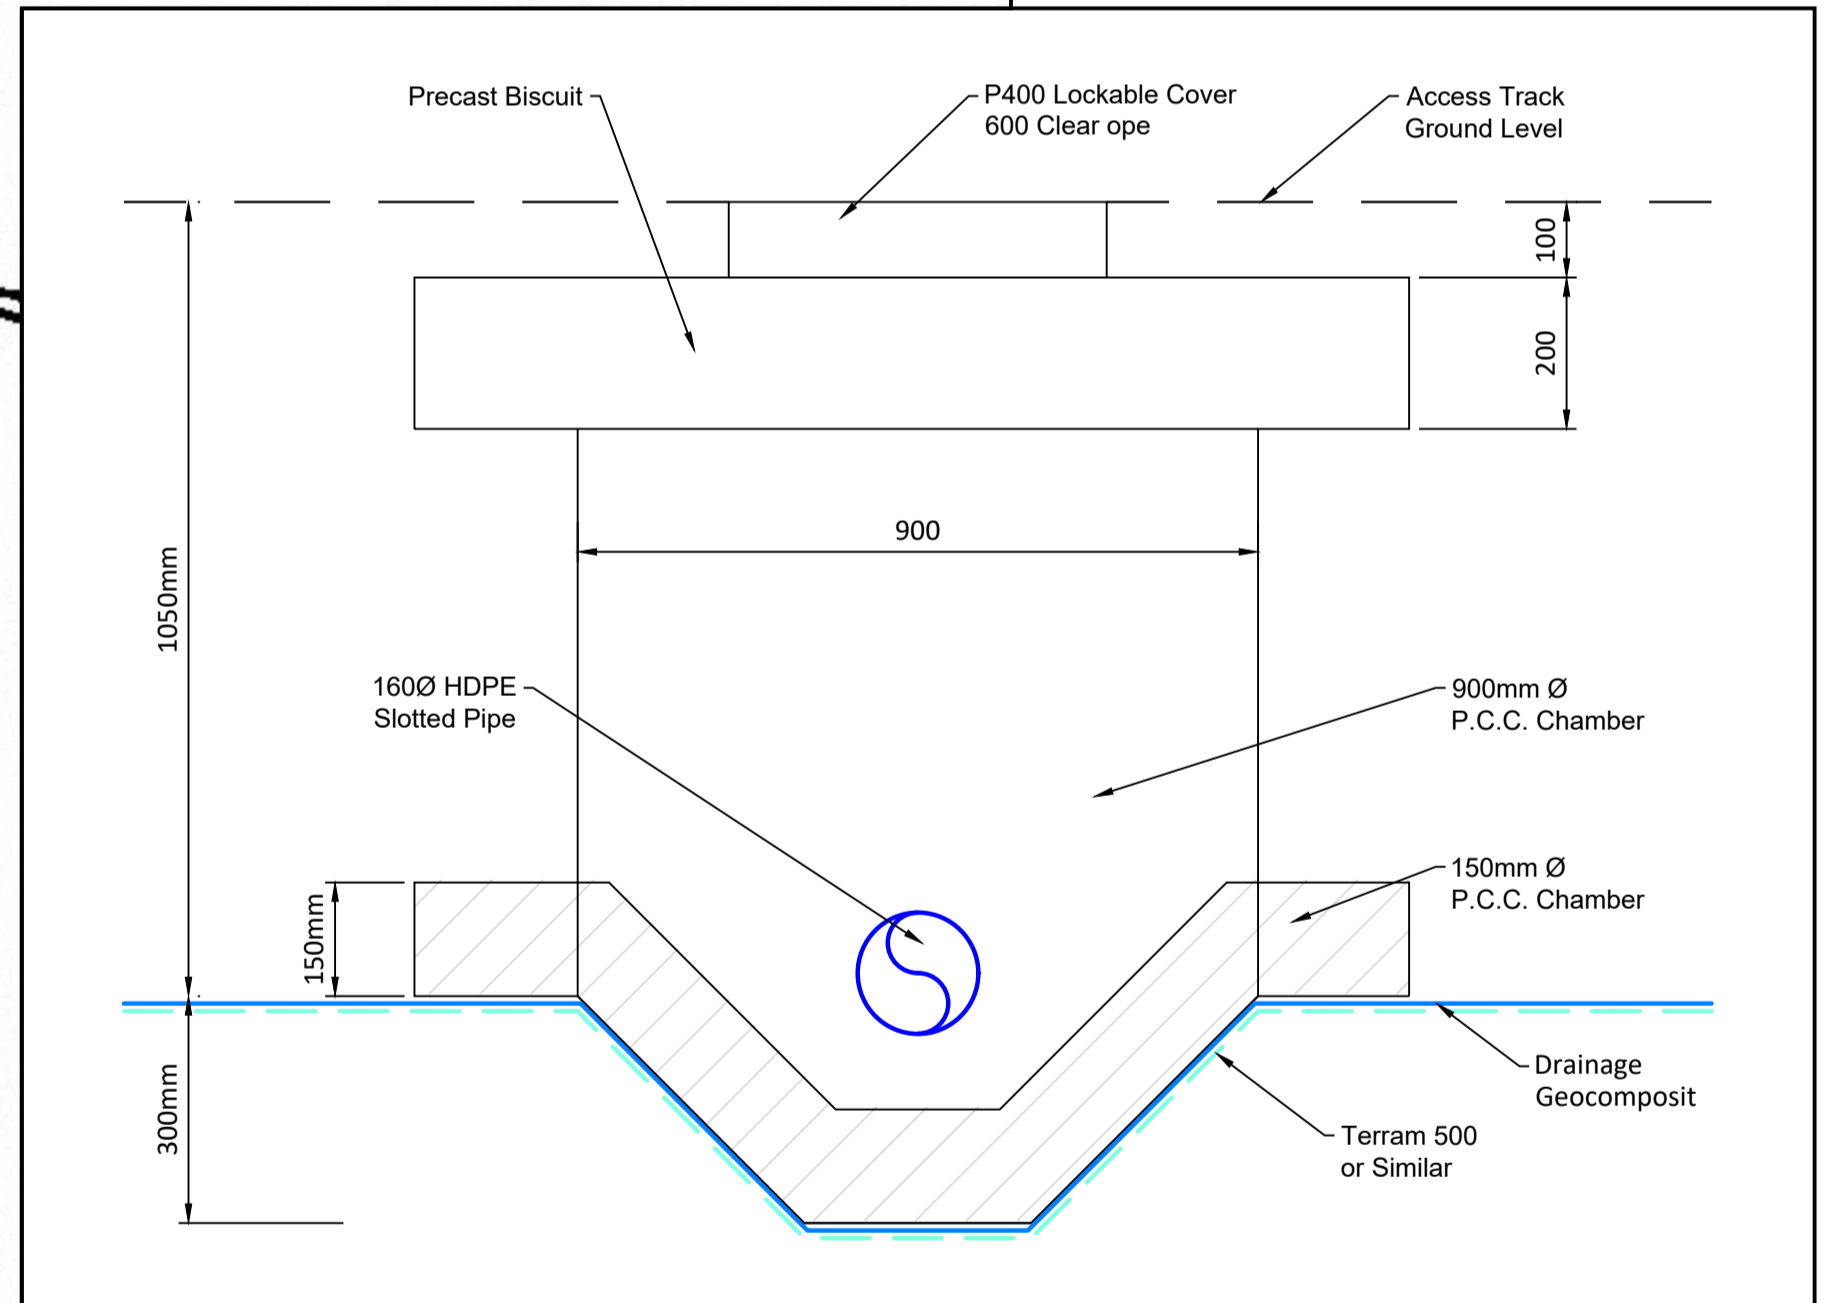

TYPICAL MANHOLE DETAIL
Scale 1:10

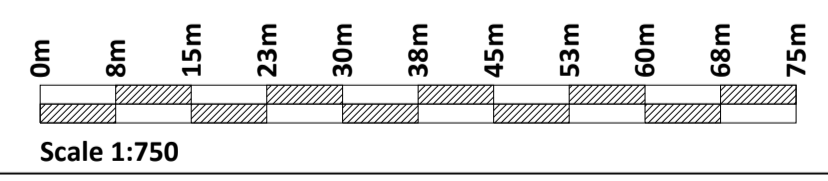

If Applicable : Ordnance Survey Ireland Licence No. EN 0001220 © Ordnance Survey Ireland and Government of Ireland OSI-3258

FEHILY TIMONEY Cork | Dublin | Carlow
www.fehilytimoney.ie

No part of this document may be reproduced or transmitted in any form or stored in any retrieval system of any nature without the written permission of Fehily Timoney & Company as copyright holder except as agreed for use on the project for which the document was originally issued. Do not scale. Use figured dimensions only. If in doubt - Ask!

Rev.	Description	App By	Date
A	ISSUE FOR PLANNING	J.O.N	17.05.22

PROJECT	CLAREMORRIS CLOSED LANDFILL: NIS AND ABP PLANNING APPLICATION		
SHEET	PROPOSED SURFACE AND SUB-SURFACE DRAINAGE		

CLIENT	MAYO COUNTY COUNCIL		
Date	17.05.22	Project number	P21-287
Drawn by	NS	Drawing Number	P21-287-0300-0001
Checked by	J.O.N	Scale (@ A1-)	1:750
Rev	A		

O:\ACAD\2021\P21-287\P21-287-0300-0001

Tuesday 17 May 2022